

Final Plans

CONTRACTOR SHALL VERIFY ALL CONDITIONS AND DIMENSIONS AT THE JOB SITE AND NOTIFY THE ARCHITECT OF ANY DIMENSIONAL ERRORS, OMISSIONS OR DISCREPANCIES BEFORE BEGINNING OR FABRICATING ANY WORK.

THESE DRAWINGS ARE THE PROPRIETARY WORK PRODUCT AND PROPERTY OF MIDWEST HOMES, INC., DEVELOPED FOR THE EXCLUSIVE USE OF MIDWEST HOMES, INC. USE OF THESE DRAWINGS AND CONCEPTS CONTAINED THEREIN WITHOUT THE WRITTEN PERMISSION OF MIDWEST HOMES, INC. IS PROHIBITED AND MAY BE SUBJECT YOU TO A CLAIM FOR DAMAGES.

Midwest Homes, Inc.

1405 E. Hwy. 50
Vermillion, SD 57069
Voice 605-624-4661
Fax 605-624-0075
www.midwesthomes.com
dave@midwestreadymix.com

Overview Elevation
| Scale: None
Client: Jackson
Date: 5/28/2014
Revision 1.6
Drawn By: Dave Hertz



Final Plans


CONTRACTOR SHALL VERIFY ALL CONDITIONS AND DIMENSIONS AT THE JOB SITE AND NOTIFY THE ARCHITECT OF ANY DIMENSIONAL ERRORS, OMISSIONS OR DISCREPANCIES BEFORE BEGINNING OR FABRICATING ANY WORK.

THESE DRAWINGS ARE THE PROPRIETARY WORK PRODUCT AND PROPERTY OF MIDWEST HOMES, INC., DEVELOPED FOR THE EXCLUSIVE USE OF MIDWEST HOMES, INC. USE OF THESE DRAWINGS AND CONCEPTS CONTAINED THEREIN WITHOUT THE WRITTEN PERMISSION OF MIDWEST HOMES, INC. IS PROHIBITED AND MAY BE SUBJECT YOU TO A CLAIM FOR DAMAGES.

Midwest Homes, Inc.

1405 E. Hwy. 50
Vermillion, SD 57069
Voice 605-624-4661
Fax 605-624-0075
www.midwesthomes.com
dave@midwestreadymix.com

Front Elevation
Scale: None IR
Client: Jackson
Date: 5/28/2014
Revision 1.6
Drawn By: Dave Hertz

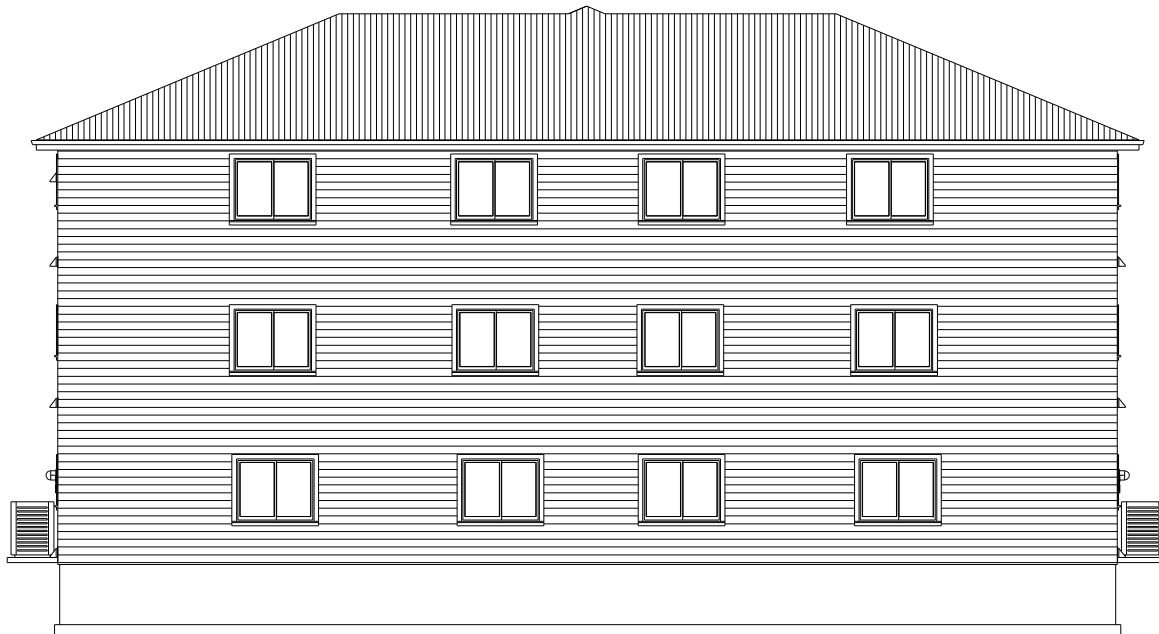

Final Plans

CONTRACTOR SHALL VERIFY ALL CONDITIONS AND DIMENSIONS AT THE JOB SITE AND NOTIFY THE ARCHITECT OF ANY DIMENSIONAL ERRORS, OMISSIONS OR DISCREPANCIES BEFORE BEGINNING OR FABRICATING ANY WORK.

THESE DRAWINGS ARE THE PROPRIETARY WORK PRODUCT AND PROPERTY OF MIDWEST HOMES, INC., DEVELOPED FOR THE EXCLUSIVE USE OF MIDWEST HOMES, INC. USE OF THESE DRAWINGS AND CONCEPTS CONTAINED THEREIN WITHOUT THE WRITTEN PERMISSION OF MIDWEST HOMES, INC. IS PROHIBITED AND MAY BE SUBJECT YOU TO A CLAIM FOR DAMAGES.

Midwest Homes, Inc.

1405 E. Hwy. 50
Vermillion, SD 57069
Voice 605-624-4661
Fax 605-624-0075
www.midwesthomes.com
dave@midwestreadymix.com

Rear Elevation
Scale: None BR
Client: Jackson
Date: 5/28/2014
Revision 1.6
Drawn By: Dave Hertz



Final Plans


CONTRACTOR SHALL VERIFY ALL CONDITIONS AND DIMENSIONS AT THE JOB SITE AND NOTIFY THE ARCHITECT OF ANY DIMENSIONAL ERRORS, OMISSIONS OR DISCREPANCIES BEFORE BEGINNING OR FABRICATING ANY WORK.

THESE DRAWINGS ARE THE PROPRIETARY WORK PRODUCT AND PROPERTY OF MIDWEST HOMES, INC., DEVELOPED FOR THE EXCLUSIVE USE OF MIDWEST HOMES, INC. USE OF THESE DRAWINGS AND CONCEPTS CONTAINED THEREIN WITHOUT THE WRITTEN PERMISSION OF MIDWEST HOMES, INC. IS PROHIBITED AND MAY BE SUBJECT YOU TO A CLAIM FOR DAMAGES.

Midwest Homes, Inc.

1405 E. Hwy. 50
 Vermillion, SD 57069
 Voice 605-624-4661
 Fax 605-624-0075
 www.midwesthomes.com
 dave@midwestreadymix.com

Right and Left Elevations
 Scale: 1/16" = 1'
 Client: Jackson
 Date: 5/28/2014
 Revision 1.6
 Drawn By: Dave Hertz

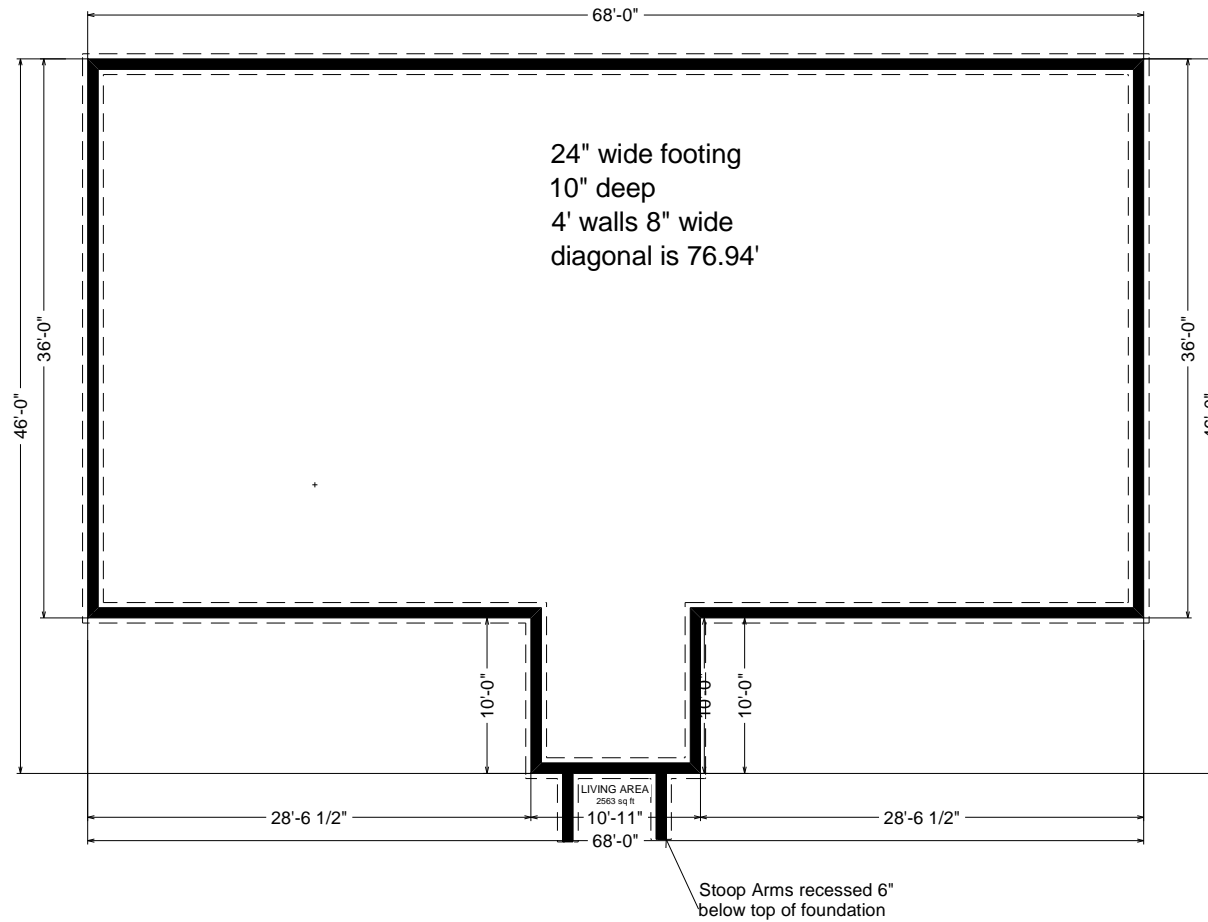

Final Plans


CONTRACTOR SHALL VERIFY ALL CONDITIONS AND DIMENSIONS AT THE JOB SITE AND NOTIFY THE ARCHITECT OF ANY DIMENSIONAL ERRORS, OMISSIONS OR DISCREPANCIES BEFORE BEGINNING OR FABRICATING ANY WORK.

THESE DRAWINGS ARE THE PROPRIETARY WORK PRODUCT AND PROPERTY OF MIDWEST HOMES, INC., DEVELOPED FOR THE EXCLUSIVE USE OF MIDWEST HOMES, INC. USE OF THESE DRAWINGS AND CONCEPTS CONTAINED THEREIN WITHOUT THE WRITTEN PERMISSION OF MIDWEST HOMES INC. IS PROHIBITED AND MAY BE SUBJECT YOU TO A CLAIM FOR DAMAGES.

Midwest Homes, Inc.

1405 E. Hwy. 50
Vermillion, SD 57069
Voice 605-624-4661
Fax 605-624-0075
www.midwesthomes.com
dave@midwestreadymix.com

Foundation
I Scale: 1/8" = 1' BR
Client: Jackson
Date: 5/28/2014
Revision 1.6
Drawn By: Dave Hertz

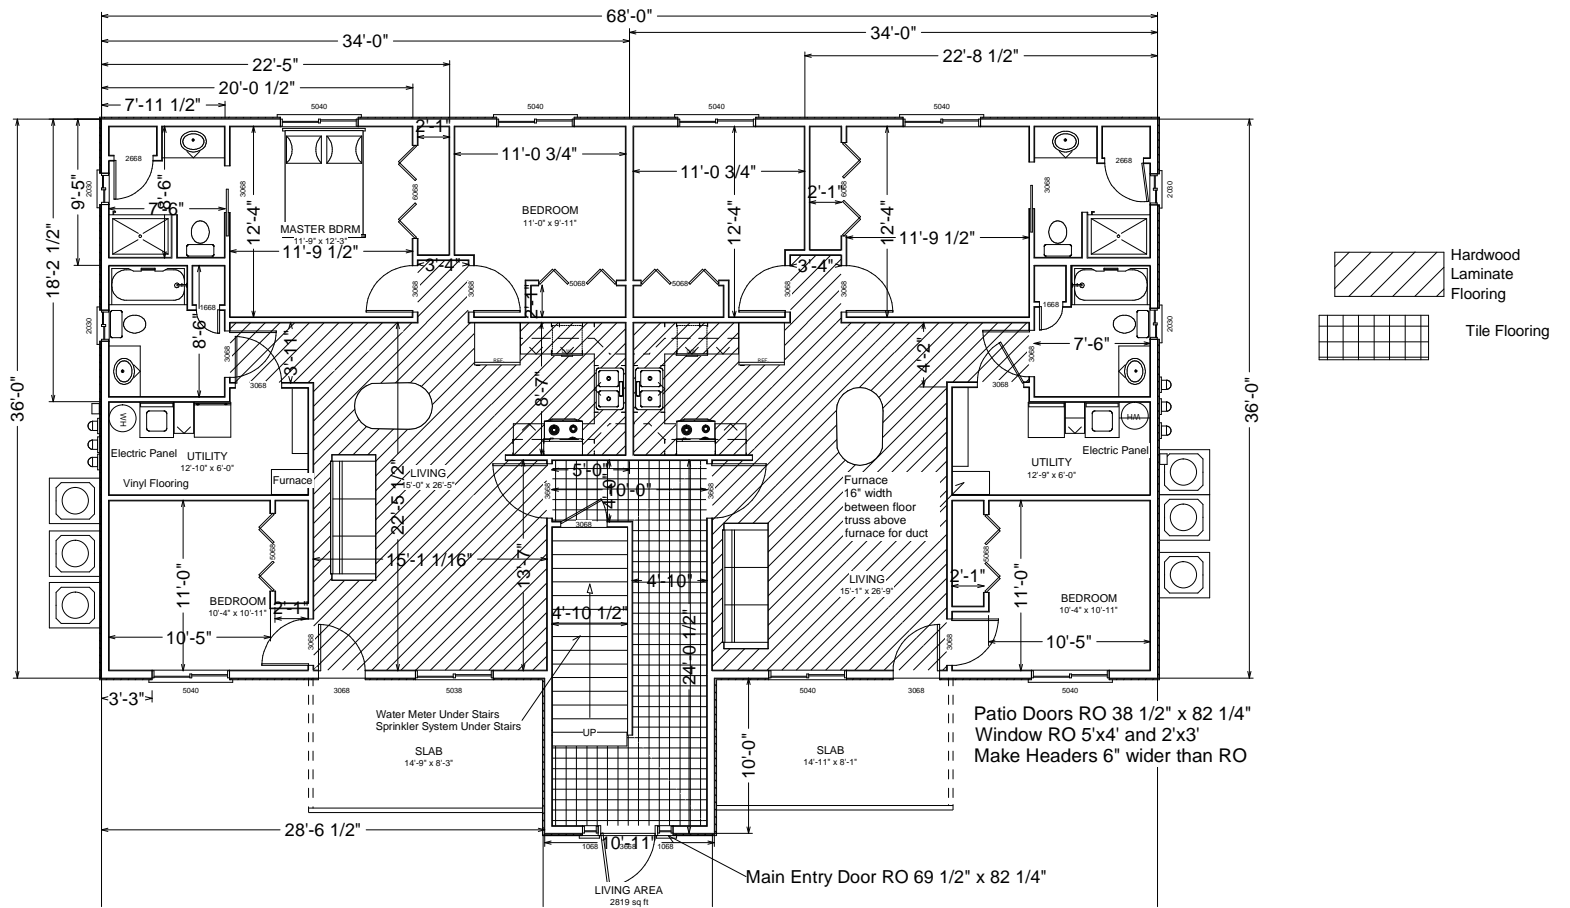

Final Plans



CONTRACTOR SHALL VERIFY ALL CONDITIONS AND DIMENSIONS AT THE JOB SITE AND NOTIFY THE ARCHITECT OF ANY DIMENSIONAL ERRORS, OMISSIONS OR DISCREPANCIES BEFORE BEGINNING OR FABRICATING ANY WORK.

THESE DRAWINGS ARE THE PROPRIETARY WORK PRODUCT AND PROPERTY OF MIDWEST HOMES, INC., DEVELOPED FOR THE EXCLUSIVE USE OF MIDWEST HOMES, INC. USE OF THESE DRAWINGS AND CONCEPTS CONTAINED THEREIN WITHOUT THE WRITTEN PERMISSION OF MIDWEST HOMES, INC. IS PROHIBITED AND MAY BE SUBJECT YOU TO A CLAIM FOR DAMAGES.

Midwest Homes, Inc.

1405 E. Hwy. 50
 Vermillion, SD 57069
 Voice 605-624-4661
 Fax 605-624-0075
 www.midwesthomes.com
 dave@midwestreadymix.com

 1st Floor
 Scale: 1/8" = 1' BR
 Client: Jackson
 Date: 5/28/2014
 Revision 1.6
 Drawn By: Dave Hertz

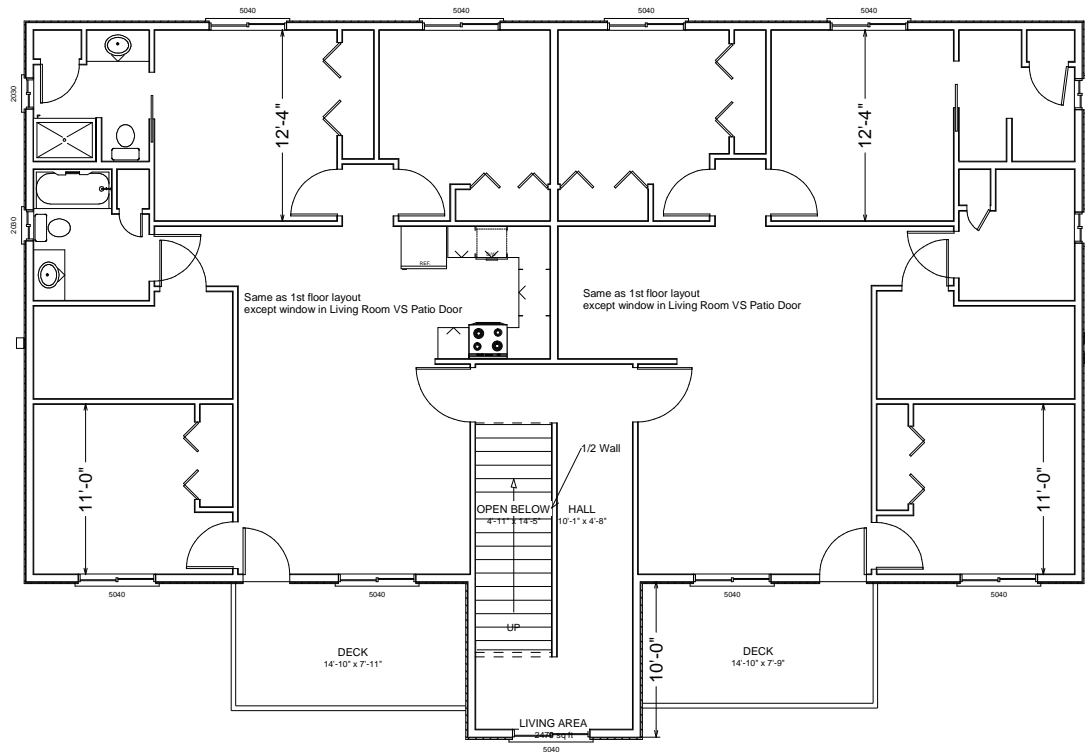

Tile Flooring

Final Plans


CONTRACTOR SHALL VERIFY ALL CONDITIONS AND DIMENSIONS AT THE JOB SITE AND NOTIFY THE ARCHITECT OF ANY DIMENSIONAL ERRORS, OMISSIONS OR DISCREPANCIES BEFORE BEGINNING OR FABRICATING ANY WORK.

THESE DRAWINGS ARE THE PROPRIETARY WORK PRODUCT AND PROPERTY OF MIDWEST HOMES, INC., DEVELOPED FOR THE EXCLUSIVE USE OF MIDWEST HOMES, INC. USE OF THESE DRAWINGS AND CONCEPTS CONTAINED THEREIN WITHOUT THE WRITTEN PERMISSION OF MIDWEST HOMES, INC. IS PROHIBITED AND MAY BE SUBJECT YOU TO A CLAIM FOR DAMAGES.

Midwest Homes, Inc.

1405 E. Hwy. 50
 Vermillion, SD 57069
 Voice 605-624-4661
 Fax 605-624-0075
 www.midwesthomes.com
 dave@midwestreadymix.com

2nd Floor Framing
 Scale: 1/8" = 1'
 Client: Jackson
 Date: 5/28/2014
 Revision 1.6
 Drawn By: Dave Hertz

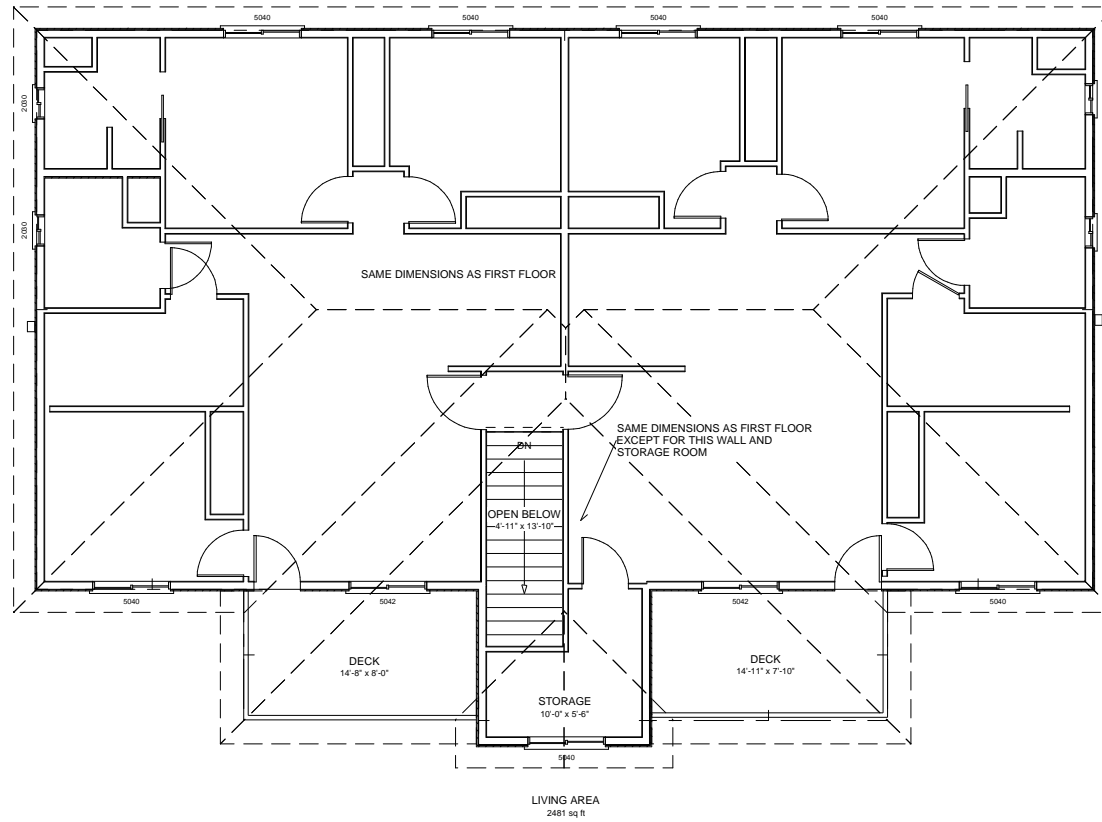

Final Plans

CONTRACTOR SHALL VERIFY ALL CONDITIONS AND DIMENSIONS AT THE JOB SITE AND NOTIFY THE ARCHITECT OF ANY DIMENSIONAL ERRORS, OMISSIONS OR DISCREPANCIES BEFORE BEGINNING OR FABRICATING ANY WORK.

THESE DRAWINGS ARE THE PROPRIETARY WORK PRODUCT AND PROPERTY OF MIDWEST HOMES, INC., DEVELOPED FOR THE EXCLUSIVE USE OF MIDWEST HOMES, INC. USE OF THESE DRAWINGS AND CONCEPTS CONTAINED THEREIN WITHOUT THE WRITTEN PERMISSION OF MIDWEST HOMES, INC. IS PROHIBITED AND MAY BE SUBJECT YOU TO A CLAIM FOR DAMAGES.

Midwest Homes, Inc.

1405 E. Hwy. 50
 Vermillion, SD 57069
 Voice 605-624-4661
 Fax 605-624-0075
www.midwesthomes.com
dave@midwestreadymix.com

3rd Floor
 Scale: 1/8" = 1' 3R
 Client: Jackson
 Date: 5/28/2014
 Revision 1.6
 Drawn By: Dave Hertz

Final Plans

CONTRACTOR SHALL VERIFY ALL CONDITIONS AND DIMENSIONS AT THE JOB SITE AND NOTIFY THE ARCHITECT OF ANY DIMENSIONAL ERRORS, OMISSIONS OR DISCREPANCIES BEFORE BEGINNING OR FABRICATING ANY WORK.

THESE DRAWINGS ARE THE PROPRIETARY WORK PRODUCT AND PROPERTY OF MIDWEST HOMES, INC. DEVELOPED FOR THE EXCLUSIVE USE OF MIDWEST HOMES, INC. USE OF THESE DRAWINGS AND CONCEPTS CONTAINED THEREIN WITHOUT THE WRITTEN PERMISSION OF MIDWEST HOMES INC. IS PROHIBITED AND MAY BE SUBJECT YOU TO A CLAIM FOR DAMAGES.


 
 

 
 

 
 
 
 
 
 
 

 
 

 









Midwest Homes, Inc.

1405 E. Hwy. 50
Vermillion, SD 57069
Voice 605-624-4661
Fax 605-624-0075
www.midwesthomes.com
dave@midwestreadymix.com

Cross Sections
Scale: None BR
Client: Jackson
Date: 5/28/2014
Revision 1.6
Drawn By: Dave Hertz

   Exit/Emer. Lite on each floor
 High performance exhaust fan in
 bath wire to lites
 include range hood

Electrical Contractors
 Any suggestions on number of
 outlets and placement

ELECTRICAL LEGEND	
SYMBOL	DESCRIPTION
	METER SOCKET
	PANEL BOX
	CEILING FAN W/ LIGHT
	FLUORESCENT LIGHT FIXTURE
	110V CEILING LIGHT FIXTURE
	110V RECESSED LIGHT FIXTURE
	110V EAVE LIGHT FIXTURE
	110V CHANDILIER LIGHT FIXTURE
	110V WALL LIGHT FIXTURE
	SINGLE POLE SWITCH
	THREE WAY SWITCH
	FOUR WAY SWITCH
	DIMMER SWITCH
	OUTDOOR SWITCH
	110V DUPLEX RECEPTACLE
	110V DUPLEX RECEPTACLE GROUND FAULT INTERRUPTED
	110V DUPLEX RECEPTACLE W/ WEATHERPROOF COVER
	110V FLOOR MOUNTED DUPLEX RECEPTACLE
	240V RECEPTACLE
	TELEPHONE JACKS
	TELEVISION JACKS
	DOOR BELL PUSH BUTTON
	THERMOSTAT
	SMOKE DETECTOR
	EXHAUST FAN
	DOOR CHIME
	FIRE ALARM PANEL
	COMPUTER POINT

Final Plans

CONTRACTOR SHALL VERIFY ALL CONDITIONS AND DIMENSIONS AT THE JOB SITE AND NOTIFY THE ARCHITECT OF ANY DIMENSIONAL ERRORS, OMISSIONS OR DISCREPANCIES BEFORE BEGINNING OR FABRICATING ANY WORK.

THESE DRAWINGS ARE THE PROPRIETARY WORK PRODUCT AND PROPERTY OF MIDWEST HOMES, INC., DEVELOPED FOR THE EXCLUSIVE USE OF MIDWEST HOMES, INC. USE OF THESE DRAWINGS AND CONCEPTS CONTAINED THEREIN WITHOUT THE WRITTEN PERMISSION OF MIDWEST HOMES INC. IS PROHIBITED AND MAY BE SUBJECT YOU TO A CLAIM FOR DAMAGES.




Midwest Homes, Inc.

1405 E. Hwy. 50
 Vermillion, SD 57069
 Voice 605-624-4661
 Fax 605-624-0075
 www.midwesthomes.com
 dave@midwestreadymix.com

Electrical Detail
 Scale: 1/4" = 1' 3R
 Client: Jackson
 Date: 5/28/2014
 Revision 1.6
 Drawn By: Dave Hertz

Moulded in Vanity sink tops
 Figure 5 shelves in each bathroom linen
 Figure shelf with rod in each closet
 Figure shelf with rod in Laundry room
 Extra shelving in laundry room

Give me some ideas on hard surface
 countertop in kitchen
 Stainless steel sink with disposal

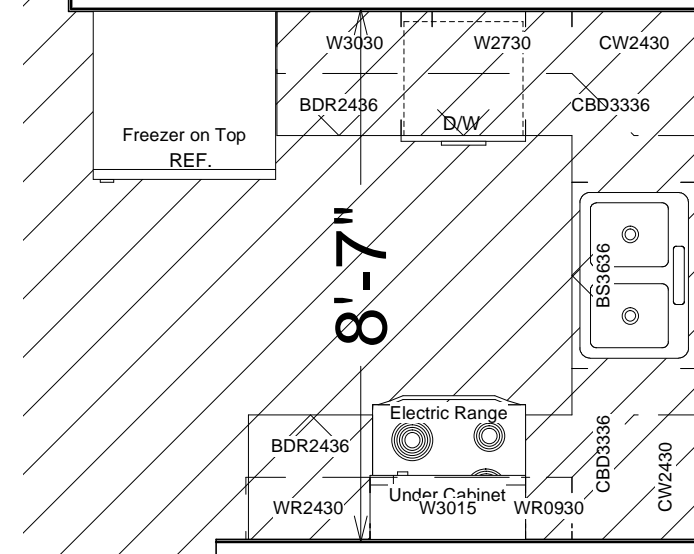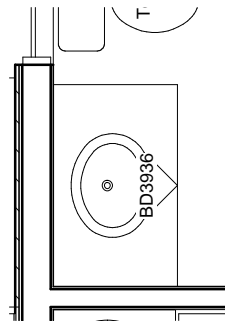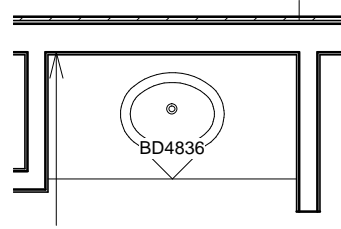

Final Plans

CONTRACTOR SHALL VERIFY ALL CONDITIONS AND DIMENSIONS AT THE JOB SITE AND NOTIFY THE ARCHITECT OF ANY DIMENSIONAL ERRORS, OMISSIONS OR DISCREPANCIES BEFORE BEGINNING OR FABRICATING ANY WORK.

THESE DRAWINGS ARE THE PROPRIETARY WORK PRODUCT AND PROPERTY OF MIDWEST HOMES, INC., DEVELOPED FOR THE EXCLUSIVE USE OF MIDWEST HOMES, INC. USE OF THESE DRAWINGS AND CONCEPTS CONTAINED THEREIN WITHOUT THE WRITTEN PERMISSION OF MIDWEST HOMES, INC. IS PROHIBITED AND MAY BE SUBJECT YOU TO A CLAIM FOR DAMAGES.

Midwest Homes, Inc.

1405 E. Hwy. 50
 Vermillion, SD 57069
 Voice 605-624-4661
 Fax 605-624-0075
 www.midwesthomes.com
 dave@midwestreadymix.com

Project: 6 Plex 3 BR
 Client: Jackson
 Date: 5/28/2014
 Revision 1.6
 Drawn By: Dave Hertz